


PC HOME CENTER CABINET PROJECT PLANNER

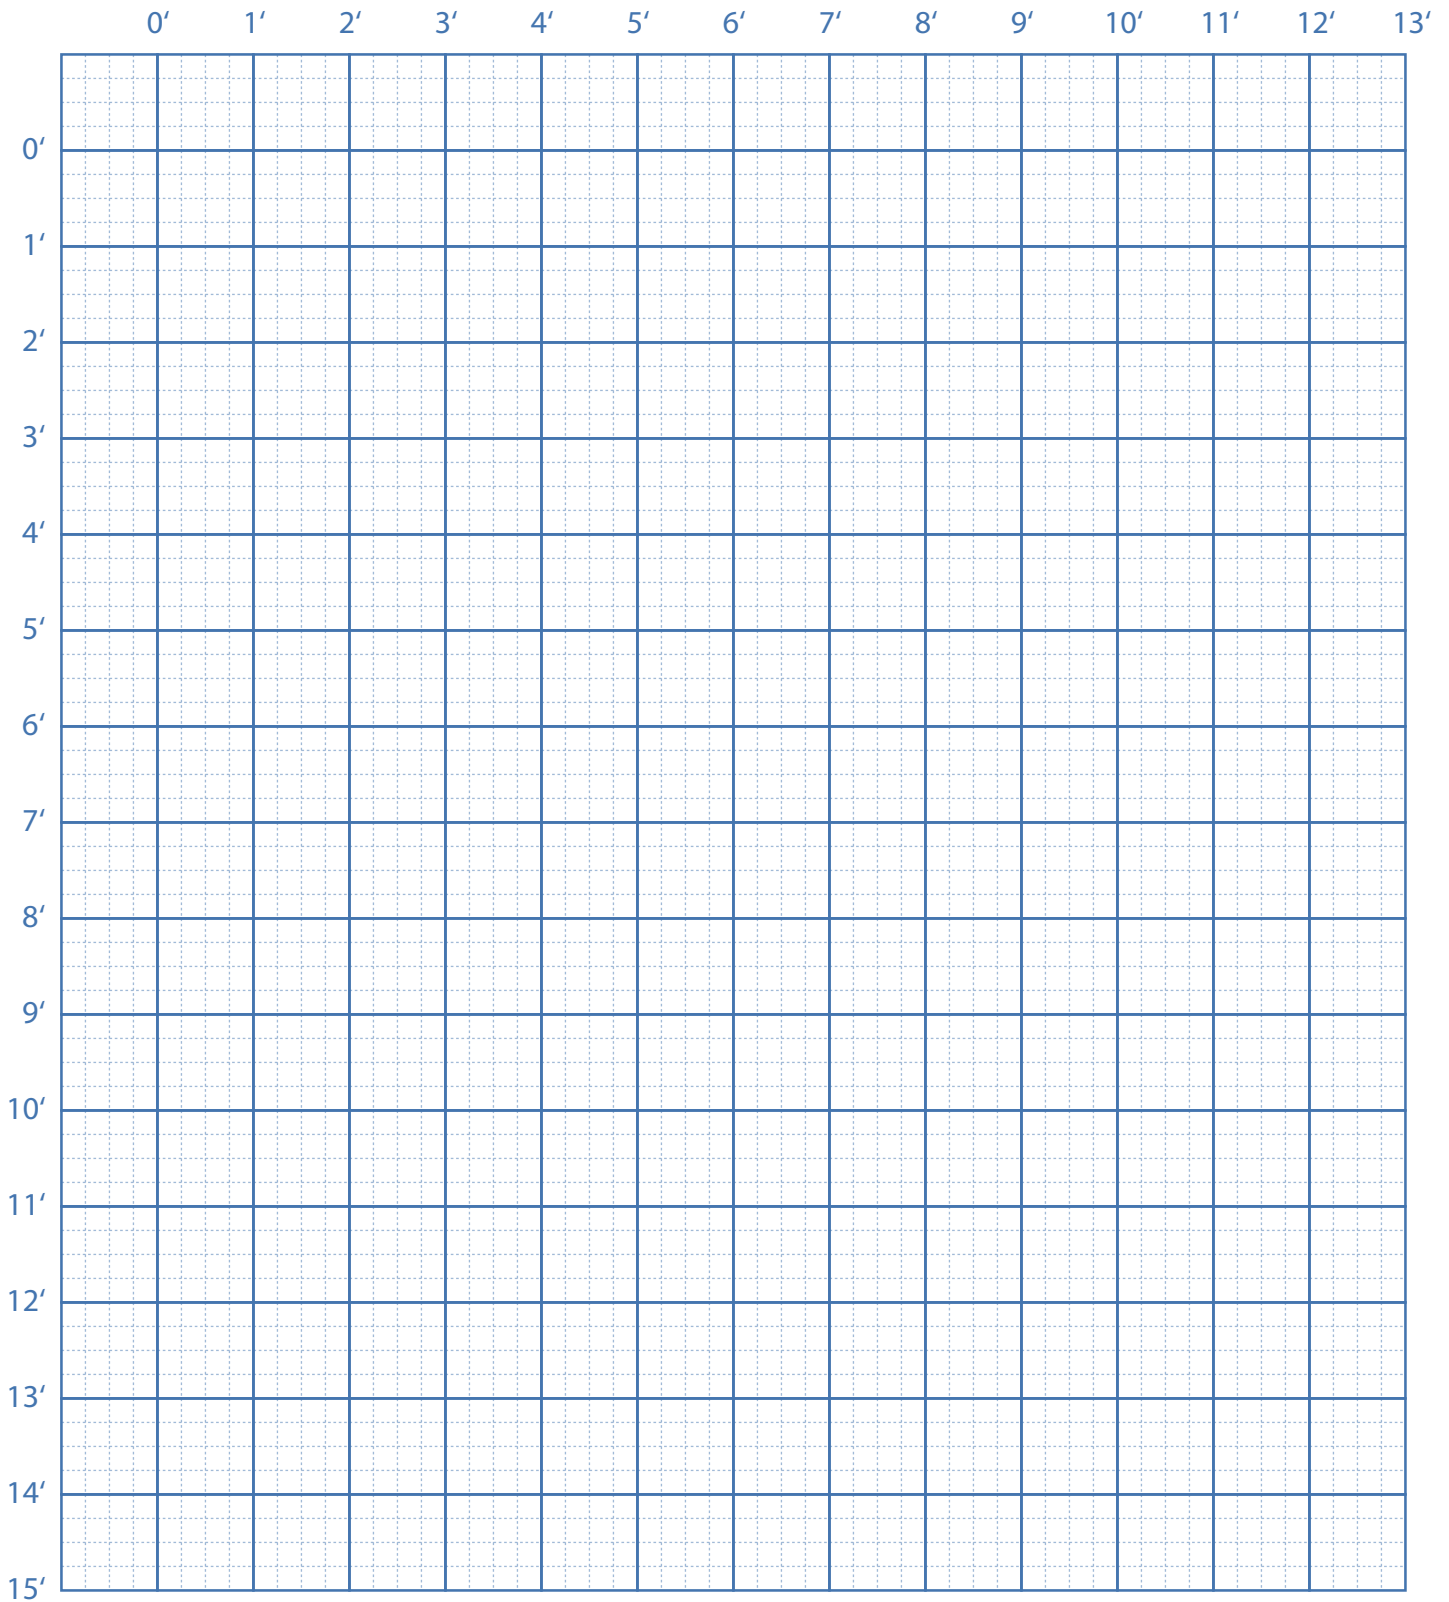

ROOM SIZE: _____ x _____

WALL HEIGHT: _____

SCALE: 1/2" = 1' - 0"

1/2" EQUALS ONE FOOT OR EACH SQUARE EQUALS THREE INCHES.
CABINETRY IS GENERALLY MADE IN 3" INCREMENTS.

OBSTACLES TO NOTE:

WINDOWS DOORS
ALCOVES STEPS
EXTERIOR WALLS LEDGES
SOFFITS

UTILITIES TO NOTE:

RECEPTACLES SWITCHES
LIGHTS GAS LINES
WATER LINES HEAT VENTS
RADIATORS

APPLIANCES

	MANUFACTURER	MODEL #	COLOR	SIZE	COST
RANGE					
COOKTOP					
OVEN(S)					
MICROWAVE					
VENTILATION/HOOD					
DISHWASHER					
WASTE DISPOSAL					
TRASH COMPACTOR					
REFRIGERATOR					
ICE MACHINE					
WINE CHILLER					
OTHER					

Supplier: _____ phone #: _____ estimate: _____

PLUMBING FIXTURES

	MANUFACTURER	MODEL #	COLOR	SIZE	COST
MAIN SINK					
MAIN FAUCET					
PREP SINK					
PREP FAUCET					
WATER FILTER					
OTHER					

Contractor: _____ phone #: _____ estimate: _____

WALL COVERINGS

	MANUFACTURER	NAME	COLOR	COST
WALLPAPER #1				
WALLPAPER #2				
BORDER				
PAINT COLOR #1				
PAINT COLOR #2				
TRIM COLOR				

Contractor: _____ phone #: _____ estimate: _____

FLOORING

floor type: wood linoleum vinyl laminate tile
 slate stone concrete carpet other

	MANUFACTURER	DESCRIPTION	COLOR	COST
MAIN AREA				
SECONDARY AREA				
OTHER				

Contractor: _____ phone #: _____ estimate: _____

LIGHTING FIXTURES

	MANUFACTURER	DESCRIPTION	QUANTITY	COST
RECESSED CANS				
PENDANTS				
CHANDELIERS				
UNDERCABINET				
COVE/VALENCE				
OTHER				

Supplier: _____ phone #: _____ estimate: _____

COUNTERTOPS

	MANUFACTURER	DESCRIPTION	COLOR	COST
COUNTERTOPS				
ISLAND				
OTHER				

Contractor: _____ phone #: _____ estimate: _____

CABINETRY

DESIGN CHOICES	
DOOR STYLE	
DOOR PANEL	
REVEAL	
HINGES	
DRAWER FRONTS	

CONSTRUCTION CHOICES	
TOE BOARD	
DRAWER BOXES	
BASE CABINET	
END PANELS	

NOTES

Instructions: Fill out as little or much information as you like. It is not necessary to complete this form, but every bit of information helps us plan for your design and installation.